


**AVAILABLE:**  
 12-8' Tables  
 10-Card Tables  
 120 Folding Chairs  
 1-Pull Down Screen  
 1-Over Head Projector  
 1-Flip Chart

Stage 15'  
 Hall 27'x50'

ADA ACCESS

MAIN GAS SHUT OFF VALVE

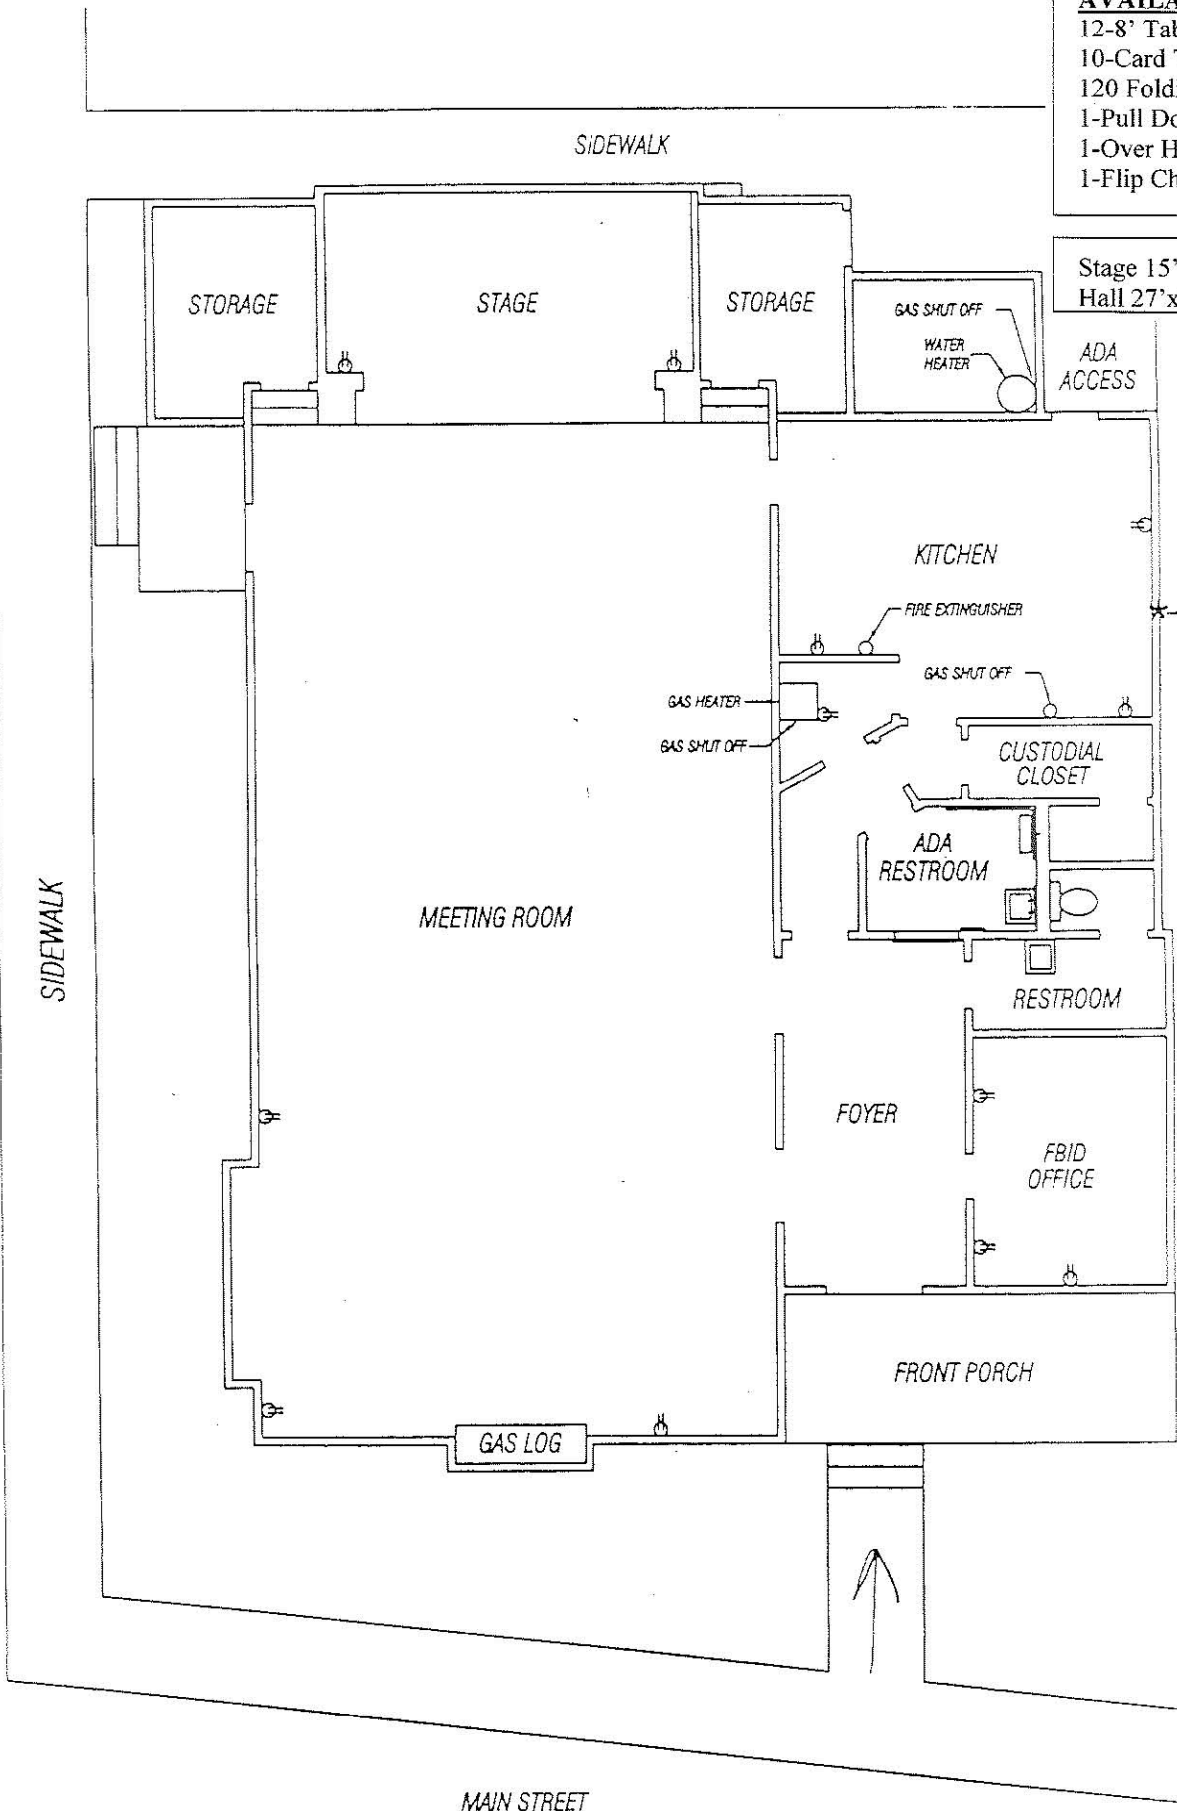

6th STREET

SIDEWALK

SIDEWALK

STORAGE

STAGE

STORAGE

GAS SHUT OFF  
 WATER HEATER

KITCHEN

FIRE EXTINGUISHER

GAS HEATER  
 GAS SHUT OFF

GAS SHUT OFF

CUSTODIAL CLOSET

ADA RESTROOM

RESTROOM

FOYER

FBID OFFICE

FRONT PORCH

GAS LOG

MAIN STREET

LEGEND

⊕ ELECTRICAL OUTLET

MONDAY CLUB FLOOR PLAN

SCALE: 1"=10'